


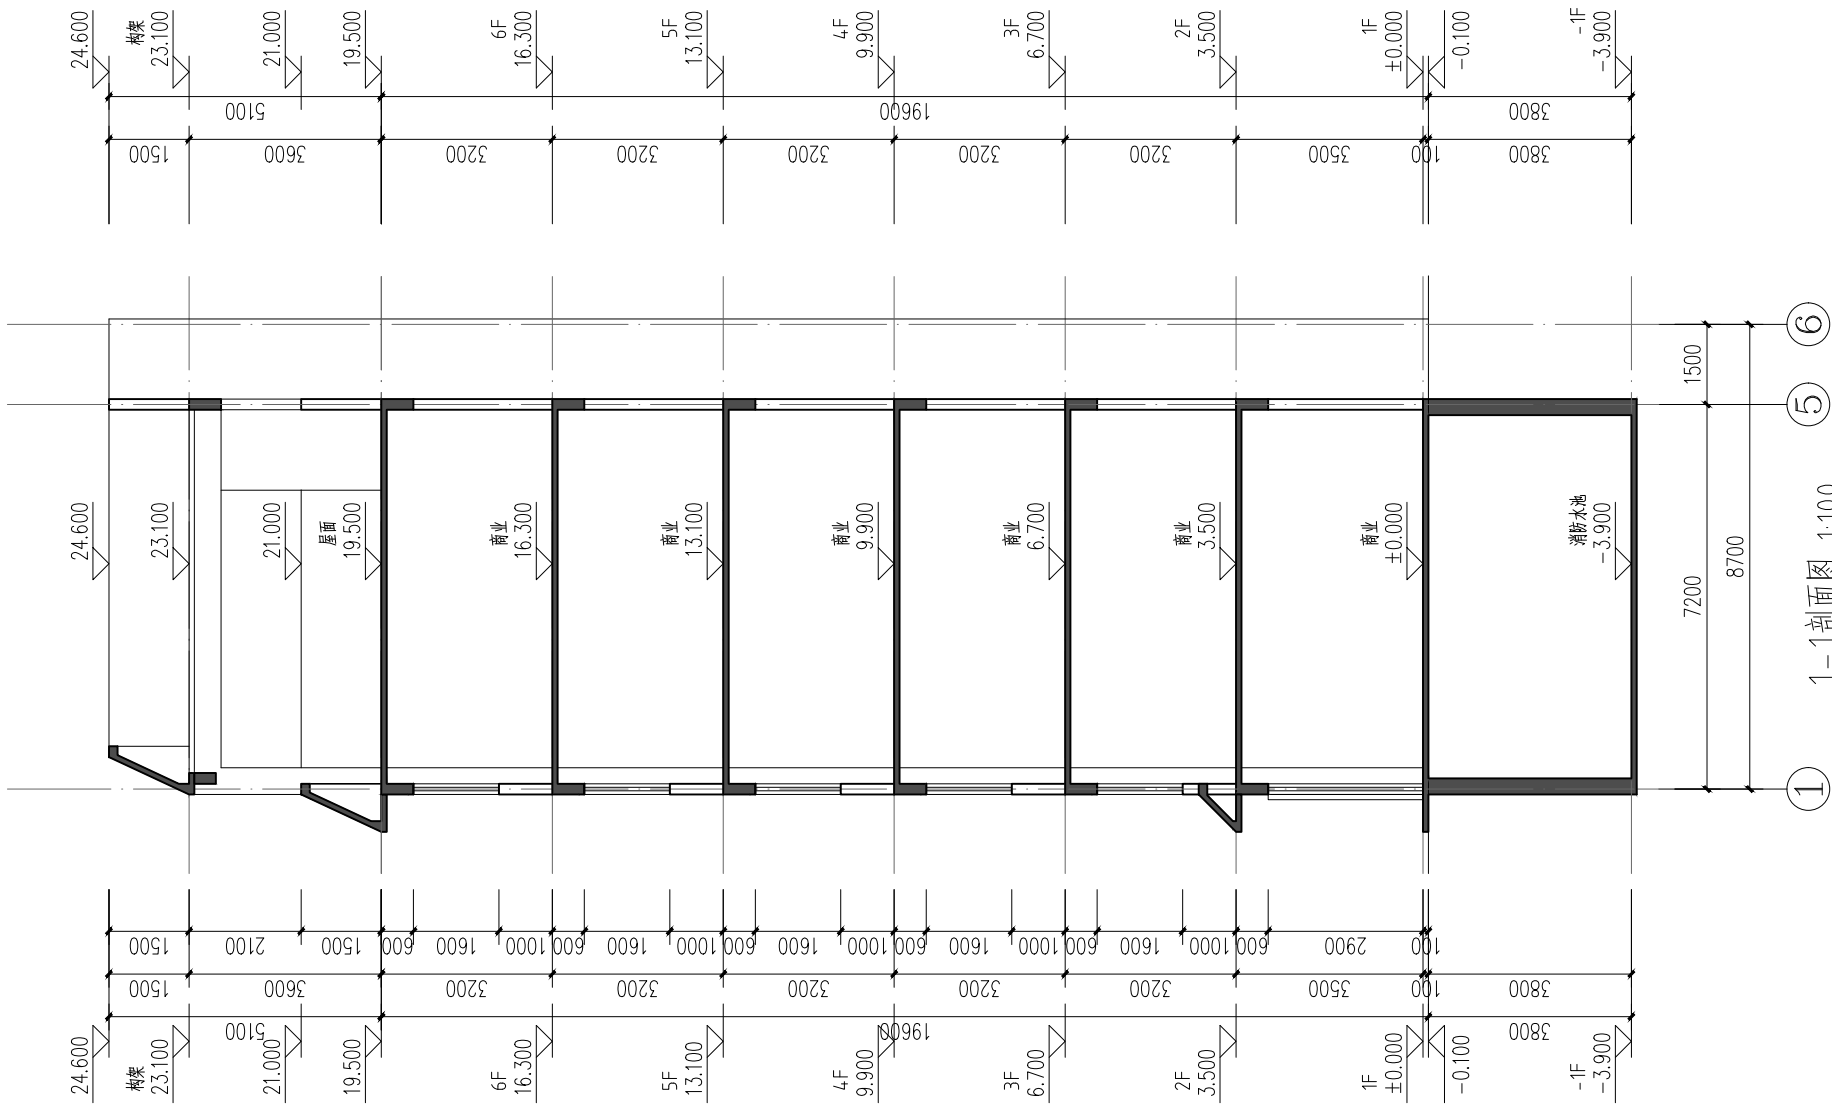

中城科泽工程设计集团有限责任公司

Zhongcheng Keze Architects&Engineers
工程设计证书编号: A232012403
本图版权归我公司所有, 除该工程外对本图的任何用途和复制, 须获得我公司的书面许可
THE OWNERSHIP OF THE COPYRIGHT IN THIS DRAWING IS RETAINED BY ZHONG CHENG KEZE ENGINEERING DESIGN CO., LTD. WRITTEN CONSENT MUST BE OBTAINED BEFORE ANY USE OR REPRODUCTION OF THE DRAWING.

合作设计单位
JOINT DESIGNER

签署栏 SIGNATURE		
制图 DRAWN BY	张伟	张伟
设计 DESIGNED BY	张伟	张伟
校对 CHECKED BY	田超	田超
专业负责人 DISCIPLINE RESPONSIBLE BY	季玉忠	季玉忠
项目负责人 PROJECT DIRECTOR BY	季玉忠	季玉忠
审核 VERIFIED BY	张伟	张伟
审定 APPROVED BY	乔恒云	乔恒云

会签栏 COUNTERSIGN			
建筑 ARCHITECTURE		电气 ELECTRIC	杜鹏飞
结构 STRUCTURE	李野	暖通 HVAC	杨品华
给排水 W, SANIT, R, S, AIR	蒋仁芳	智能 AUTO	

建设单位 CLIENT	三江县东九达贸易有限公司		
工程名称 PROJECT	东悦商业大厦		
图纸名称 DRAWING TITLE	1-1剖面图		
设计编号 DESIGN NO.		图号 DRAWING NO.	建方 07
设计阶段 STATUS	方案设计	版次 VERSION	
比例 SCALE	1:100	日期 DATE	2026. 06